



FRONT ELEVATION

 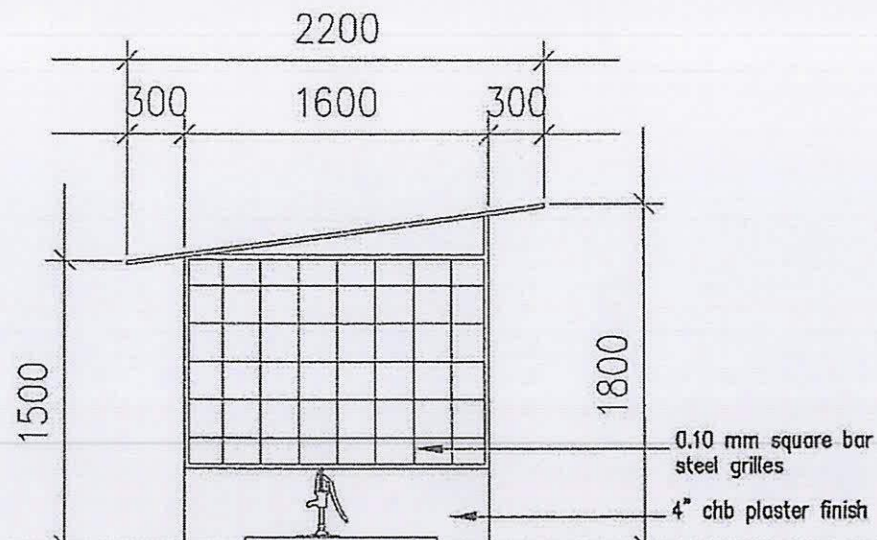


RIGHTSIDE ELEVATION

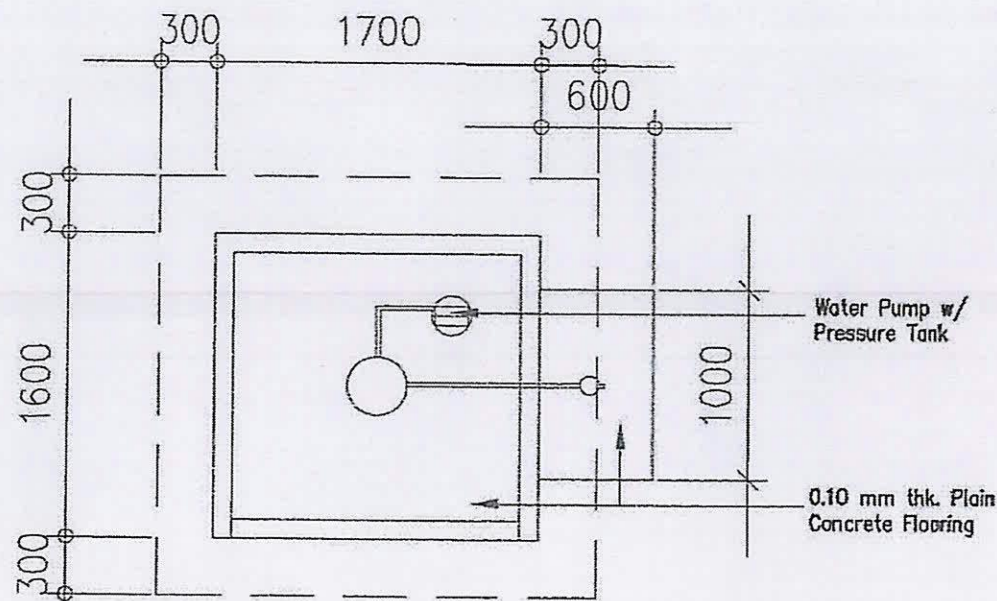

PLAN

OFFICE :



PROJECT TITLE :

PROVINCIAL JAIL WATER SYSTEM  
AT BOGTONG, LEGAZPI CITY

DRAWN / CADD BY

LEANA K. CHAVENIA

PREPARED BY :

RUELO D. SORIANO


CHECKED BY :

EFREN E. ROSANA

APPROVED BY :

DANTE B. BACLAO

SHEET NO.

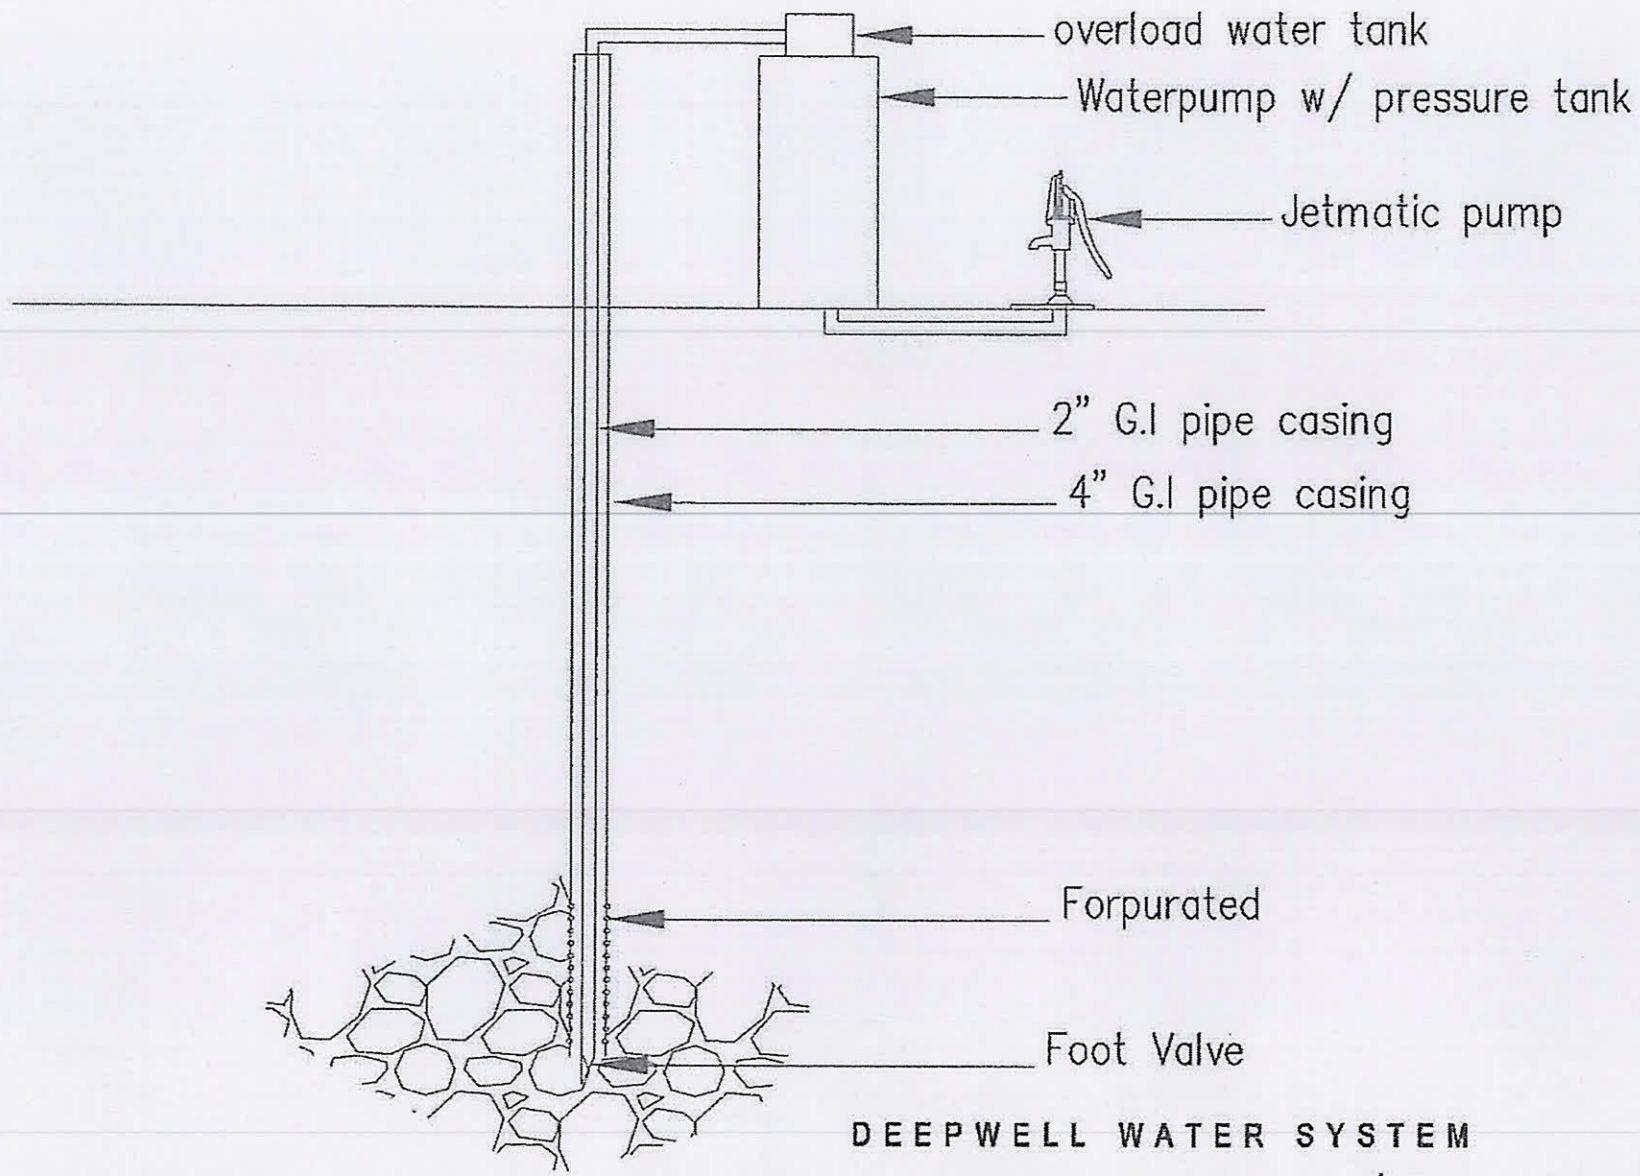

DEEPWELL WATER SYSTEM

OFFICE :	PROJECT TITLE :	DRAWN / CADD BY :	PREPARED BY :	CHECKED BY :	APPROVED BY :	SHEET NO.
Republic of the Philippines Province of Albay <b>PROVINCIAL ENGINEERS OFFICE</b> Construction and Maintenance Division Silgoon, Comilla, Jolo	<b>PROVINCIAL JAIL WATER SYSTEM          AT BOGTONG, LEGAZPI CITY</b>	 <b>LEANA A. CHAVENIA</b>	 <b>RUELO D. SORIAO</b>	 <b>EFREN E. ROSANA</b>	 <b>DANTE B. BACIAO</b>	